


Do Not Duplicate

unless prior written approval has been obtained from a qualified representative from Campbell-Sevey, Inc.
(952) 935-2345

CONDENSATE PACKAGE TRIM LIST			
ITEM NO.	QTY.	ITEM	DESCRIPTION
1	1	PUMP	FLOWSERVE
2	1	FLEX CONNECTION	4" X 30"
3	1	FLEX CONNECTION	3" X 30"
4	1	CONTROL VALVE	SPENCE MODEL BOSS - 3"
5	1	GATE VALVE	4" VELAN GATE VALVE
6	1	CHECK VALVE	DURABLA 4" - WLC
7	1	CHECK VALVE	DURABLA 1.5" - WLC
8	2	GATE VALVE	1.5" VELAN GATE VALVE
9	1	ORIFICE PLATE	0.25" THICK ORIFICE PLATE
10	1	LIQUID LEVEL SWITCH	ENDRESS & HAUSER MODEL FTL51
11	1	PRESSURE TRANSMITTER	ENDRESS & HAUSER MODEL PMP71 (VAPOR)
12	1	GOAL POST ASSEMBLY	0.5" 300# AIR VENT / VACUUM BREAKER
13	1	TANK	WHEELER
14	1	GAUGE GLASS	MODEL 516 - BRONZE
15	1	LIQUID LEVEL SWITCH	ENDRESS & HAUSER MODEL FTL51
16	1	PRESSURE TRANSMITTER	ENDRESS & HAUSER MODEL FMD77
17	1	GATE VALVE	6" VELAN GATE VALVE
18	1	FLEX CONNECTION	1.5" X 18"
19	1	GLOBE VALVE	3" VELAN GLOBE VALVE

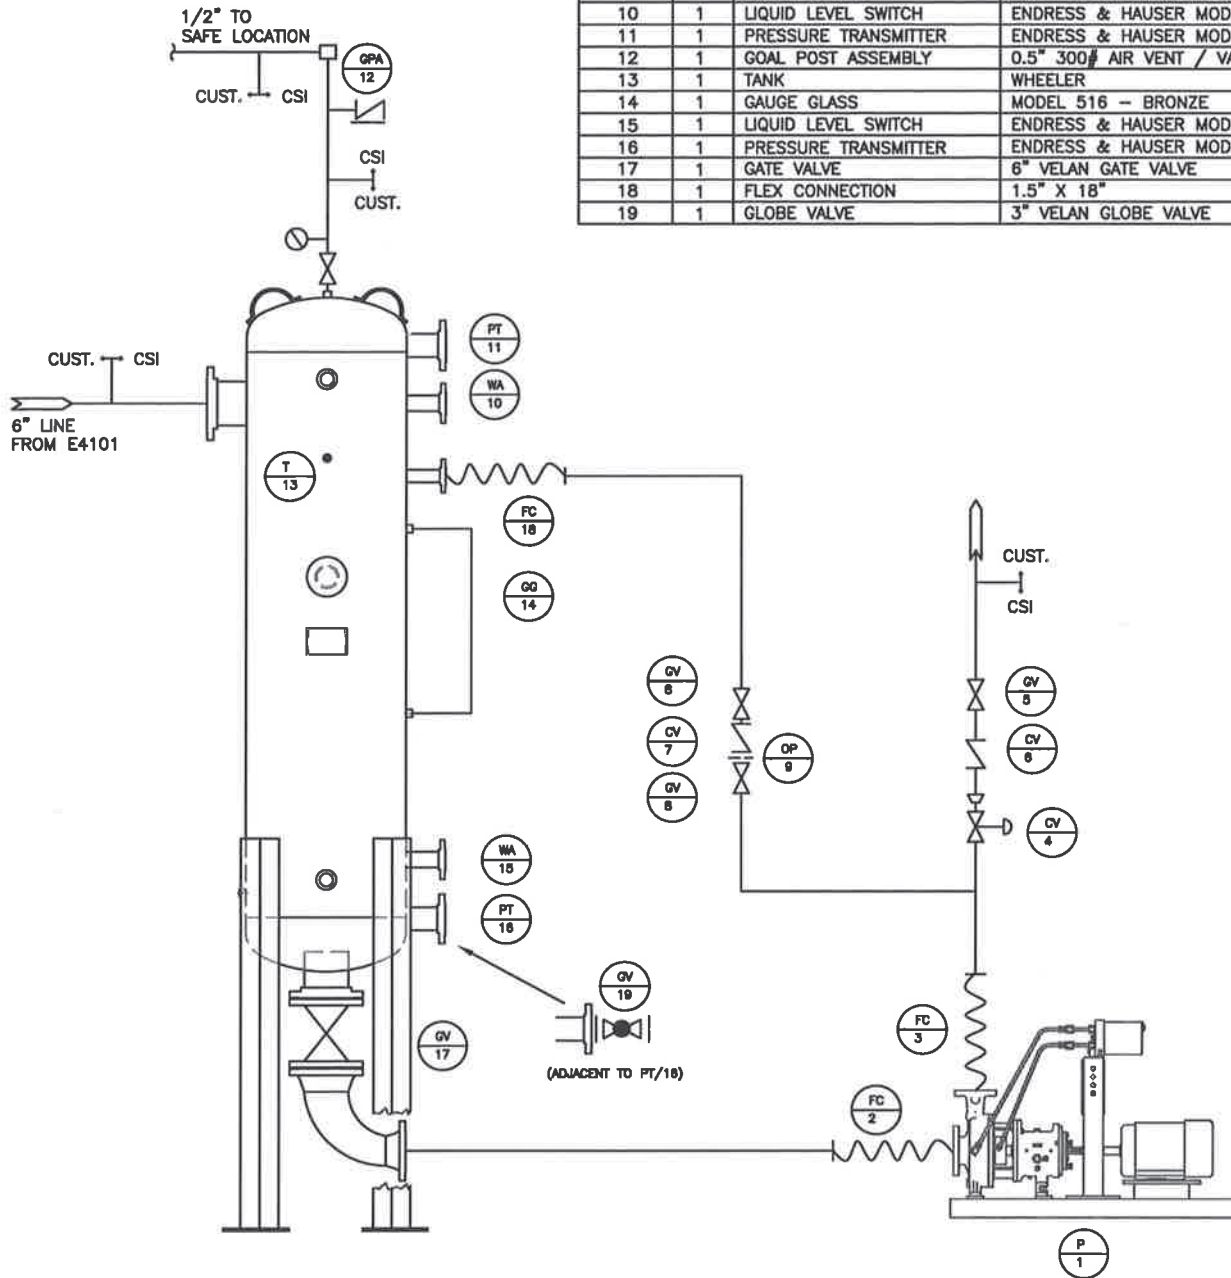

TAG: Z-4101 CONDENSATE PACKAGE

MAX 100 PSIG • 338 DEG. F

REVISIONS

ZONE	REV	DESCRIPTION	DATE	APPROVED
	0	Original Drawing	10-25-06	
	1	REVISED	2-9-07	



CAMPBELL-SEVEY, INC.

PROJECT: DELTA-T, BUNGE-ERGON

DRAWING NAME: CONDENSATE RETURN SYSTEM P&ID

SIZE B	SCALE: NTS	DWG NO. 61310-500	REV 1
-----------	------------	----------------------	----------